
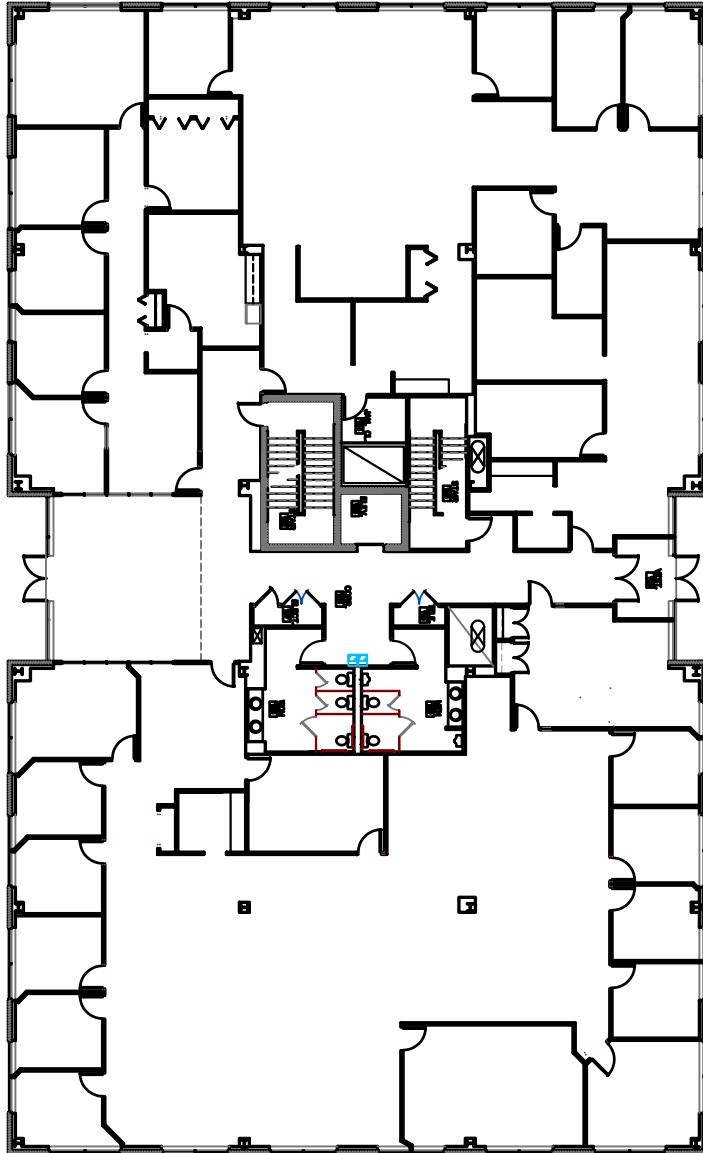


LOWER LEVEL FLOOR PLAN  
SCALE = 1/8" = 1'

MECHANICAL FLOOR PLAN = 10/22/04

LOWER LEVEL FLOOR PLAN	<p>   <b>BUILDER / DEVELOPER</b>          1800 CORPORATE WOODS PKY.          P.O. BOX 2018          AKRON, OHIO 44308          PHONE: 330-499-3200          FAX: 330-499-3204       </p>	<p> <b>INTERLAKE CORPORATE CENTER 1</b>          4199 KINROSS LAKES PKWY          RICHFIELD, OHIO       </p>	<p>         11/15/03          11/15/03       </p>
A1	<p>         designed by          G-20          date 1-1-04          drawn by       </p>		



FIRST FLOOR PLAN  
1/8" = 1'

FIRST FLOOR PLAN - 2004.04

Architects

**INTERLAKE CORPORATE CENTER 1**  
4199 KINROSS LAKES PKWY  
RICHFIELD, OHIO


**CSM INC.**  
BUILDER / DEVELOPER  
1800 CORPORATE SQUARE NW  
PALM BEACH, FLORIDA 33411  
TEL: 561-833-4333  
FAX: 561-833-4333

Architect No.  
6-10  
Scale  
1/8" = 1'-0"  
Drawn By

FIRST FLOOR PLAN

A2

SECOND FLOOR PLAN  
1/8" = 1'

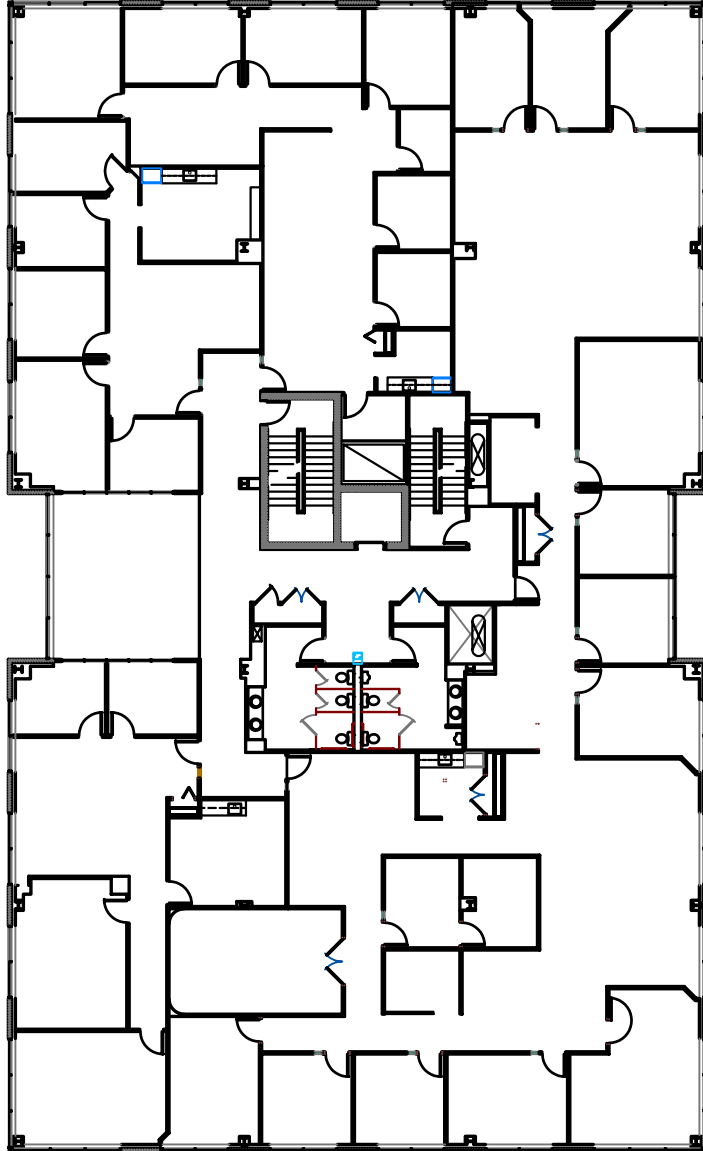

FORMER FLOOR PLAN - 10/20/07

Architects

**INTERLAKE CORPORATE CENTER 1**  
4199 KINROSS LAKES PKWY  
RICHFIELD, OHIO

**CSM INC.**  
BUILDER / DEVELOPER  
1800 CORPORATE WOODS PKY.  
P.O. BOX 2018  
MARIETTA, OHIO 43026  
202-499-3823


Architect No.  
Date  
Scale  
Drawn By

SECOND FLOOR PLAN

A3

THIRD FLOOR PLAN  
 1/8" = 1' - 0"

PRINTED FROM REV. 01/2014

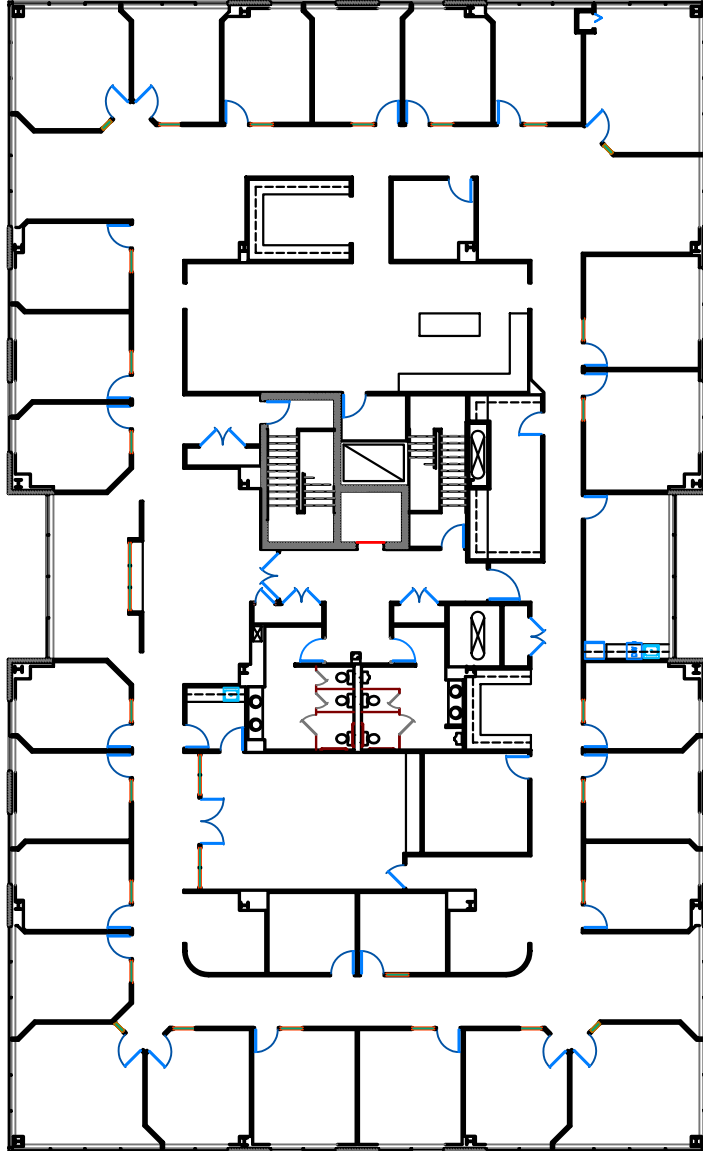

THIRD FLOOR PLAN

A4

continued on  
 sheet C-30  
 drawn by

**CSM**  
 INC.  
 BUILDER / DEVELOPER  
 1800 CORPORATE SQUARE NW  
 F.A. BOX 2018  
 JARVIS, OHIO 43030  
 614-444-3333

**INTERLAKE CORPORATE CENTER 1**  
 4199 KINROSS LAKES PKWY  
 RICHFIELD, OHIO

Architects